


REFLECTED CEILING PLAN
SCALE: 1/4" = 1'-0"

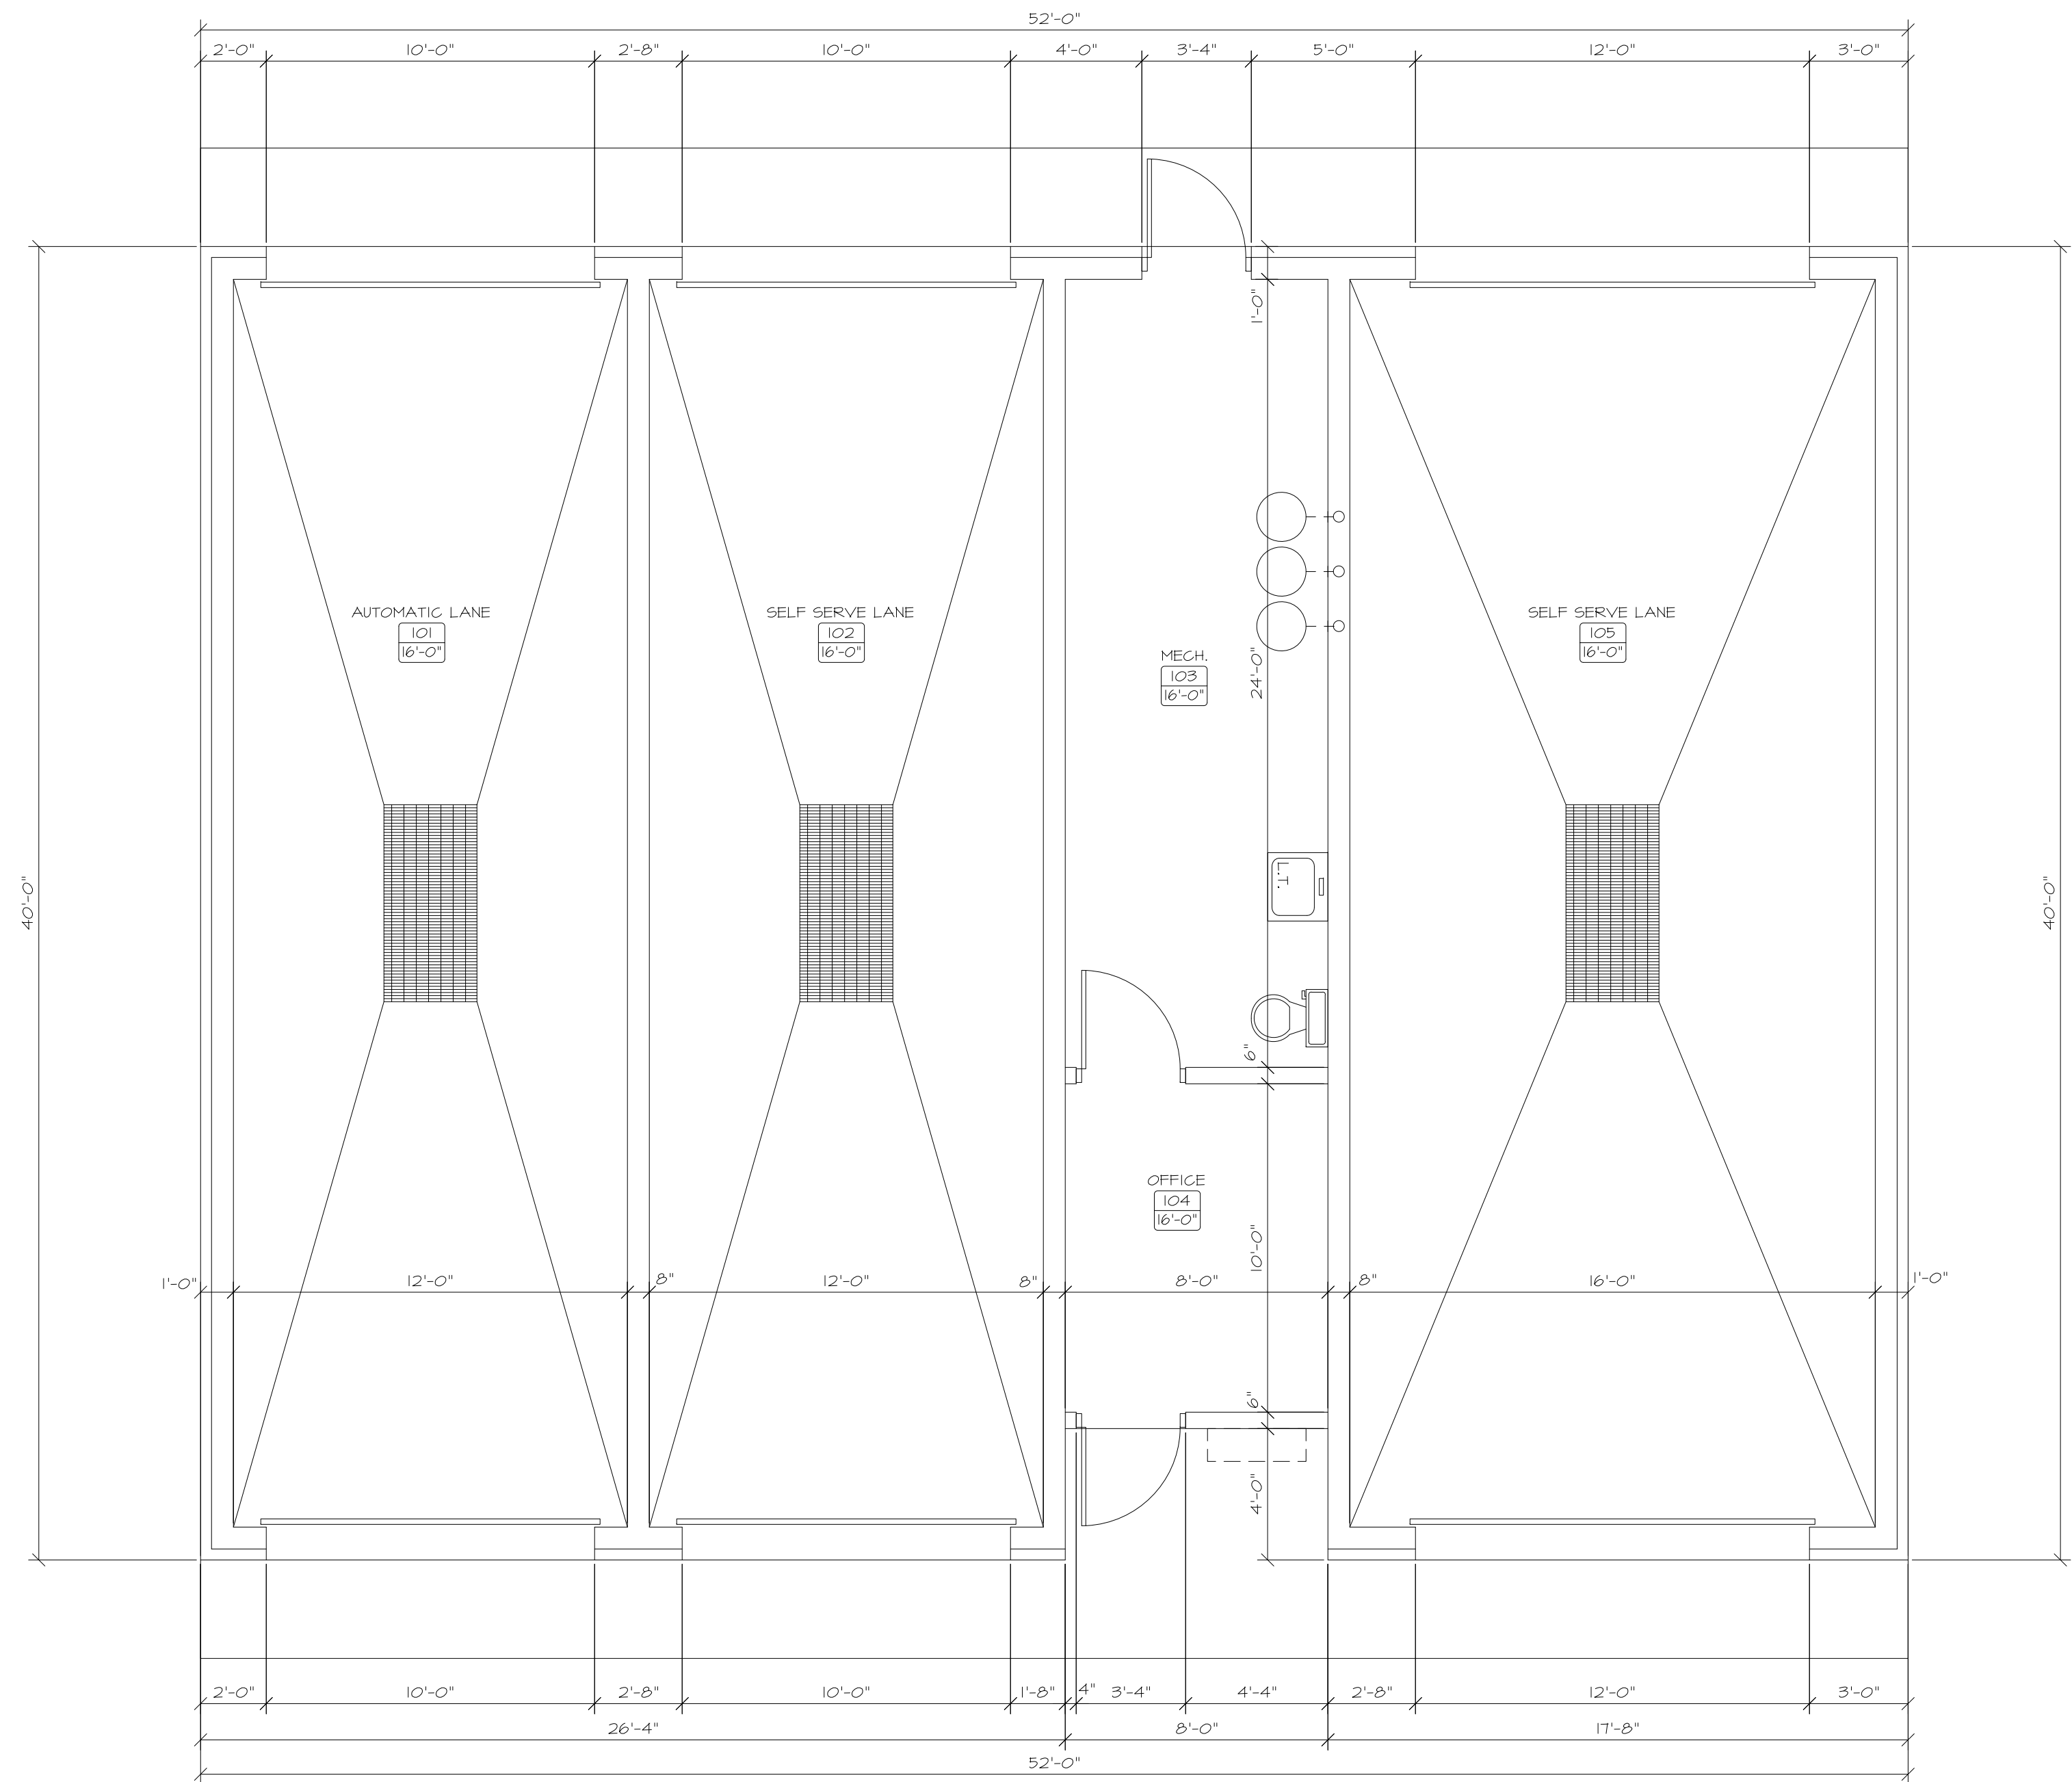

FLOOR PLAN
SCALE: 1/4" = 1'-0"

- SYMBOLS LIST**
- ⊕ GFI
 - ⊕ RECEPTACLE - DUPLEX
 - ⊕ RECEPTACLE - QUAD
 - ▼ WALL MOUNTED TELEPHONE/DATA OUTLET
 - AV AUDIO/VISUAL ALARM
 - M MANUAL ALARM PULL STATION
 - T THERMOSTAT
 - E EXISTING TO REMAIN

NOTE:
SECURITY WIRING & LOW VOLTAGE DATA/INTERNET WIRING TO BE PROVIDED & INSTALLED BY TENANT.

REVISIONS	BY

FLOOR PLAN
REFLECTED CEILING PLAN
WALL TYPES

NEW BUILDING FOR:
JOHNSBURG GARWASH
JOHNSBURG ROAD
JOHNSBURG, ILLINOIS 60051

R.B. CUSTOM DESIGNS INC.
2108 N. Johnsburg Road
Johnsburg, Illinois 60051
Phone: 815-756-4454
Fax: 815-307-8200

Date: 7/28/23
Scale: AS NOTED
Drawn: RJB
Job: 202322
Sheet: A-2
OF: 2 Sheets

© COPYRIGHT 2023